

**ARCHITECTS REGISTRATION BOARD /
NOMINATED ARCHITECTS**

NSW	QLD
8356 NNWOTSCHKA TITCHKOSKY	5527 NEIL LOGAN
4937 JAMES GROCE	2709 BRIAN DOMOVAN
7115 JULIAN ASHTON	1596 MARK GRIMMER
2435 NAL THEW LABAY	5528 DAVID KELLY
7151 PHILLIP ROSSINGTON	3866 KEVIN O'BRIEN
7439 PETER TITMUS	
10447 ALISON BOUNDS	
10766 CATHERINE SKINNER	
Telephone +61 2 8297 7200	
Facsimile +61 2 8297 7299	
www.bvni.com.au	

INTELLECTUAL PROPERTY

COPYRIGHT BUN ARCHITECTURE PTY LIMITED. UNLESS OTHERWISE AGREED IN WRITING ALL RIGHTS TO THIS DOCUMENT ARE SUBJECT TO PAYMENT IN FULL OF ALL BUN CHARGES. THIS DOCUMENT MAY ONLY BE USED FOR THE EXPRESS PURPOSE AND PROJECT FOR WHICH IT HAS BEEN CREATED AND DELIVERED, AS NOTIFIED IN WRITING BY BUN AND THIS DOCUMENT MAY NOT BE: OTHERWISE USED, OR COPIED ANY UNAUTHORISED USE OF THIS DOCUMENT IS AT THE USER'S SOLE RISK AND WITHOUT LIMITING BUN'S RIGHTS THE USER RELEASES AND INDEMNIFIES BUN FROM AND AGAINST ALL LOSS SO ARISING.

NOTE
CONTRACTOR TO CHECK AND VERIFY ALL DIMENSIONS ON SITE PRIOR
TO COMMENCEMENT OF WORK OR PREPARATION OF SHOP DRAWINGS.
DO NOT SCALE THIS DRAWING

ISSUE	DATE	FOR
01	07/10/2021	SSDA ISSUE
02	15/10/2021	SSDA SUBMISSION
03	30/11/2021	70% DD ISSUE
04	22/12/2021	80% DD ISSUE
05	18/03/2022	SSDA RIS
06	12/04/2022	BOUNDARIES UPDATED
07	05/06/2022	FOR TENDER
08	21/12/2022	DRAFT SSDA MODIFICATION
09	17/01/2023	DRAFT SSDA MODIFICATION
10	17/01/2023	SSDA MODIFICATION
11	13/02/2023	SSDA MODIFICATION
12	15/02/2023	FOR INFORMATION
13	21/02/2023	FOR INFORMATION
14	21/02/2023	FOR INFORMATION
15	17/03/2023	FOR INFORMATION

CONSULTANT
TURF LANDSCAPE
TEL 02 8394 9990

CONSULTANT
LCI
TEL 02 9157 0570

CONSULTANT
TTW
TEL 02 9439 7288

CONSULTANT
PTC
TEL 02 8920 0800

CONSULTANT
GROUP DLA
TEL 02 8355 3160

CONSULTANT
WSP
M 0425 440 213

PROJECT MANAGER
WALKER CORPORATION
TEL 02 8273 9630

**NOT FOR
CONSTRUCTION**

CLIENT
WESTERN SYDNEY UNIVERSITY

PROJECT
LANG WALKER AO MEDICAL
RESEARCH BUILDING -
MACARTHUR, CAMPBELLTOWN

BVN PROJECT NUMBER
2011004

DRAWING KEY

TRUE NORTH

PROJECT NORTH

GRAPHIC SCALE

0 10000 25000

SCALE

1: 500@B1

STATUS

100% DESIGN DEVELOPMENT

DRAWING

PROPOSED SITE PLAN	
DRAWING NUMBER	ISSUE
BVN-AR-10A A00-003	15





PECAN LIGHTING
NXT-48M-350mA-2LB-3000K
LIGHTING DISTRIBUTION TYPE II
53W
MOUNTING HEIGHT 2.5m

A-CLASS HOARDING
(plywood hoarding fixed to
concrete counterweights)

UNISTRUT SYSTEM

FLOOD LIGHT

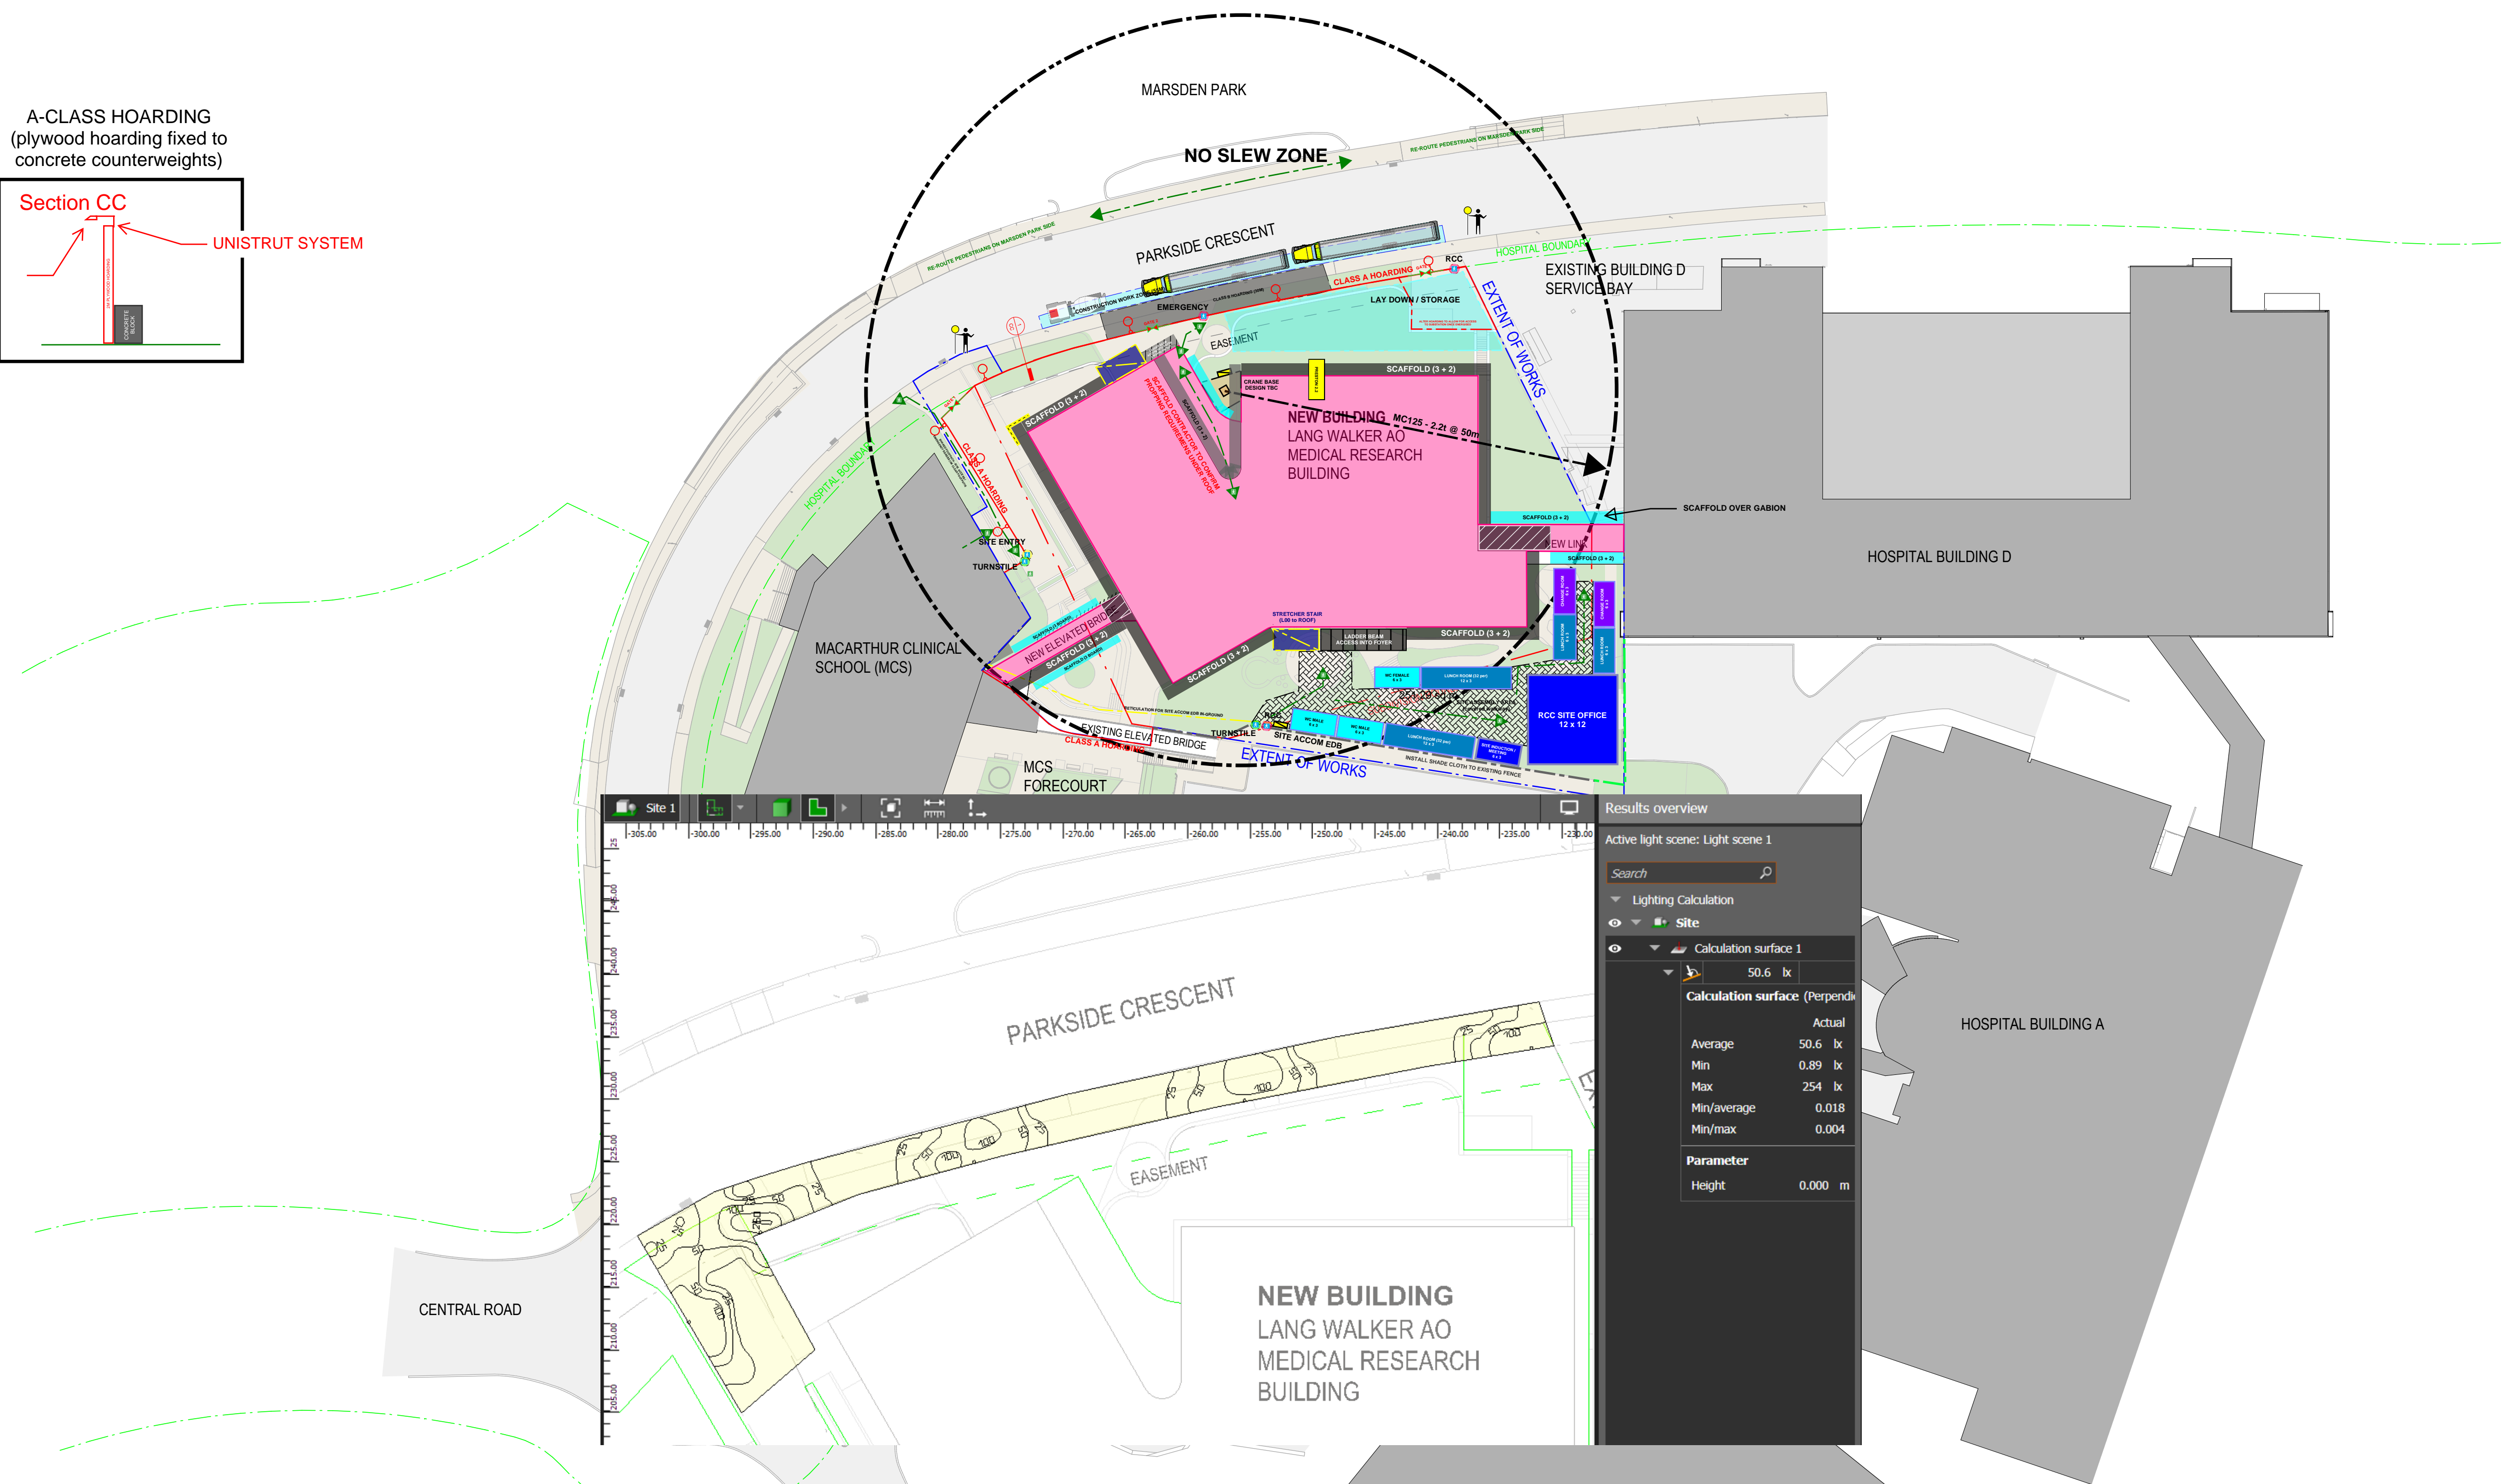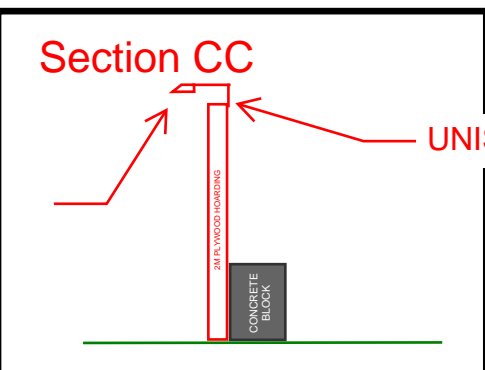

Pedestrian	Mixed vehicle	Ave horizontal	Min horizontal	Max/Ave horizontal	Min Vertical
PP1	high risk of crime	10	2	5	1
PP2	high pedestrian activity, medium crime,	7	1	5	0.3
PP3	medium pedestrian activity, medium crime	3	0.5	5	0.1

OUTDOOR LIGHTING PLAN